

[illegible]

CONTRACT DATE:	03/31/2022
BUILDING TYPE:	END. MED 40
PLAN VERSION:	SEPT. 2021
BRAND DESIGNER:	
SITE NUMBER:	315669
ENTITY NUMBER:	458169
PA/PM:	
DRAWN BY.:	
JOB NO.:	22204

**ENDEAVOR 2.0**  
SPEARS CREEK CHURCH RD  
(BY LIBERTY RIDGE DRIVE)  
SOUTH CAROLINA 29229





## ENDEAVOR 2.0

### WALL SECTIONS

## A5.2

PLOT DATE: 5/18/2022 2:21:52 PM

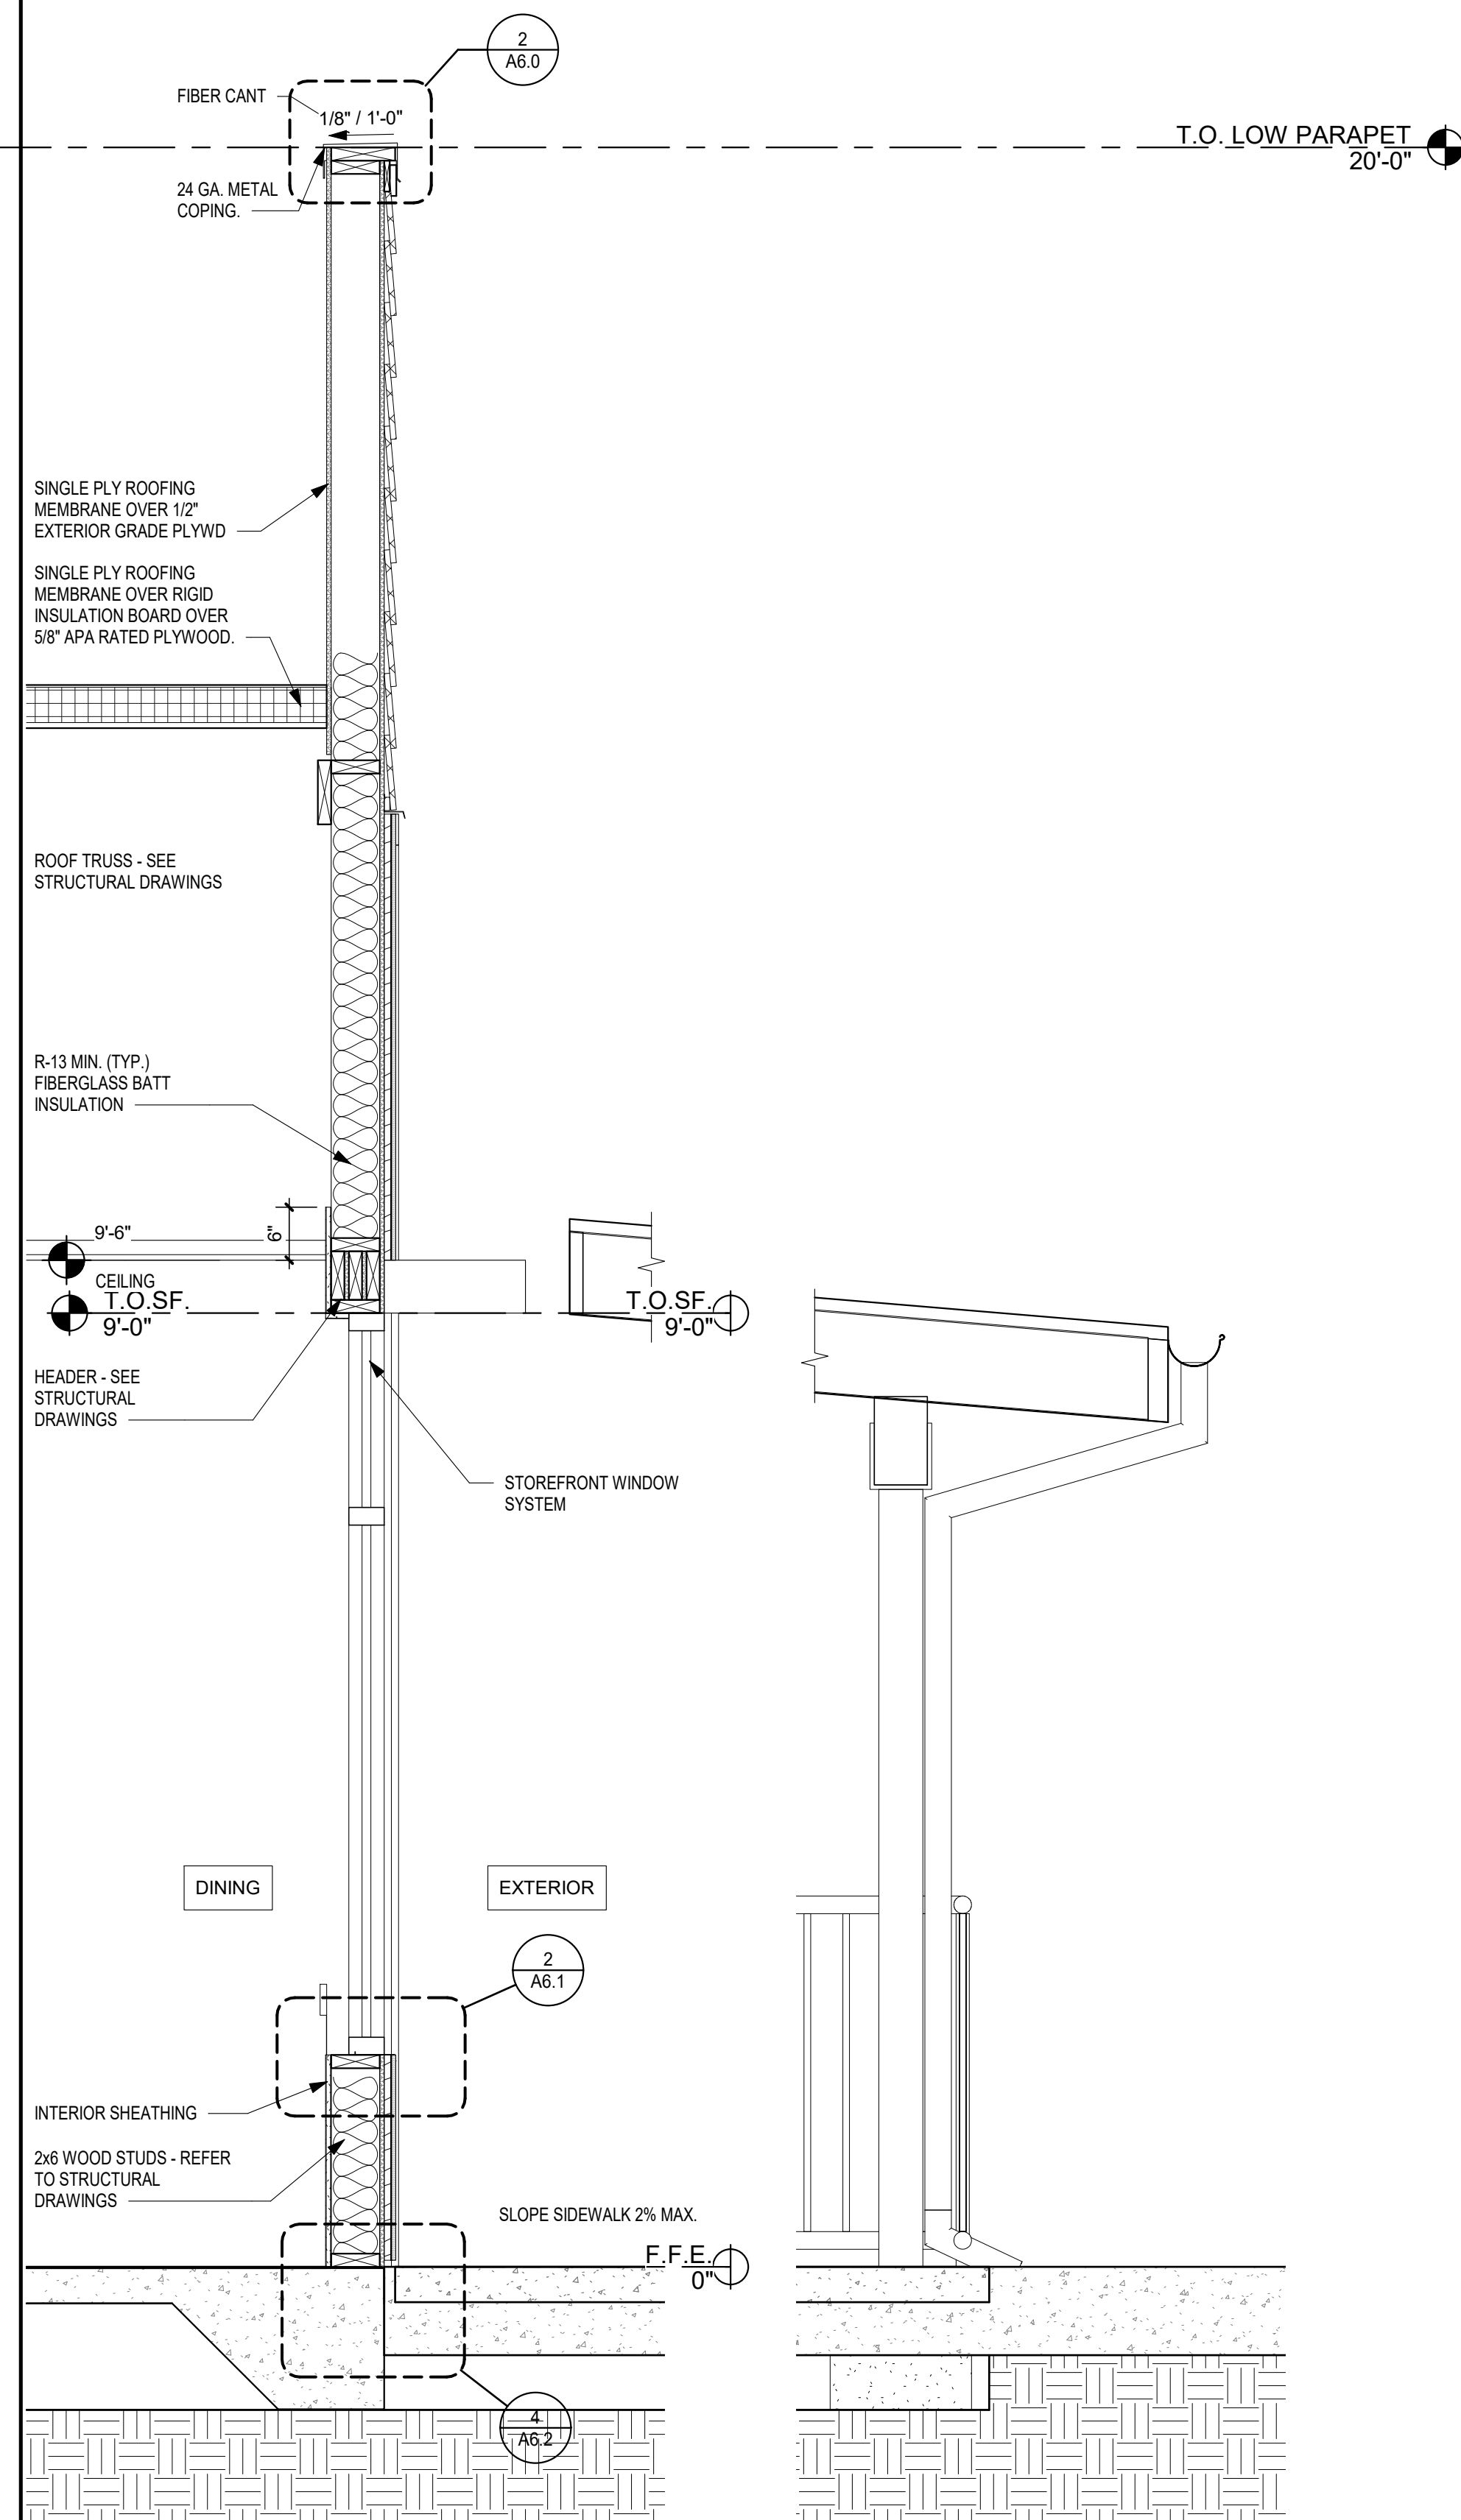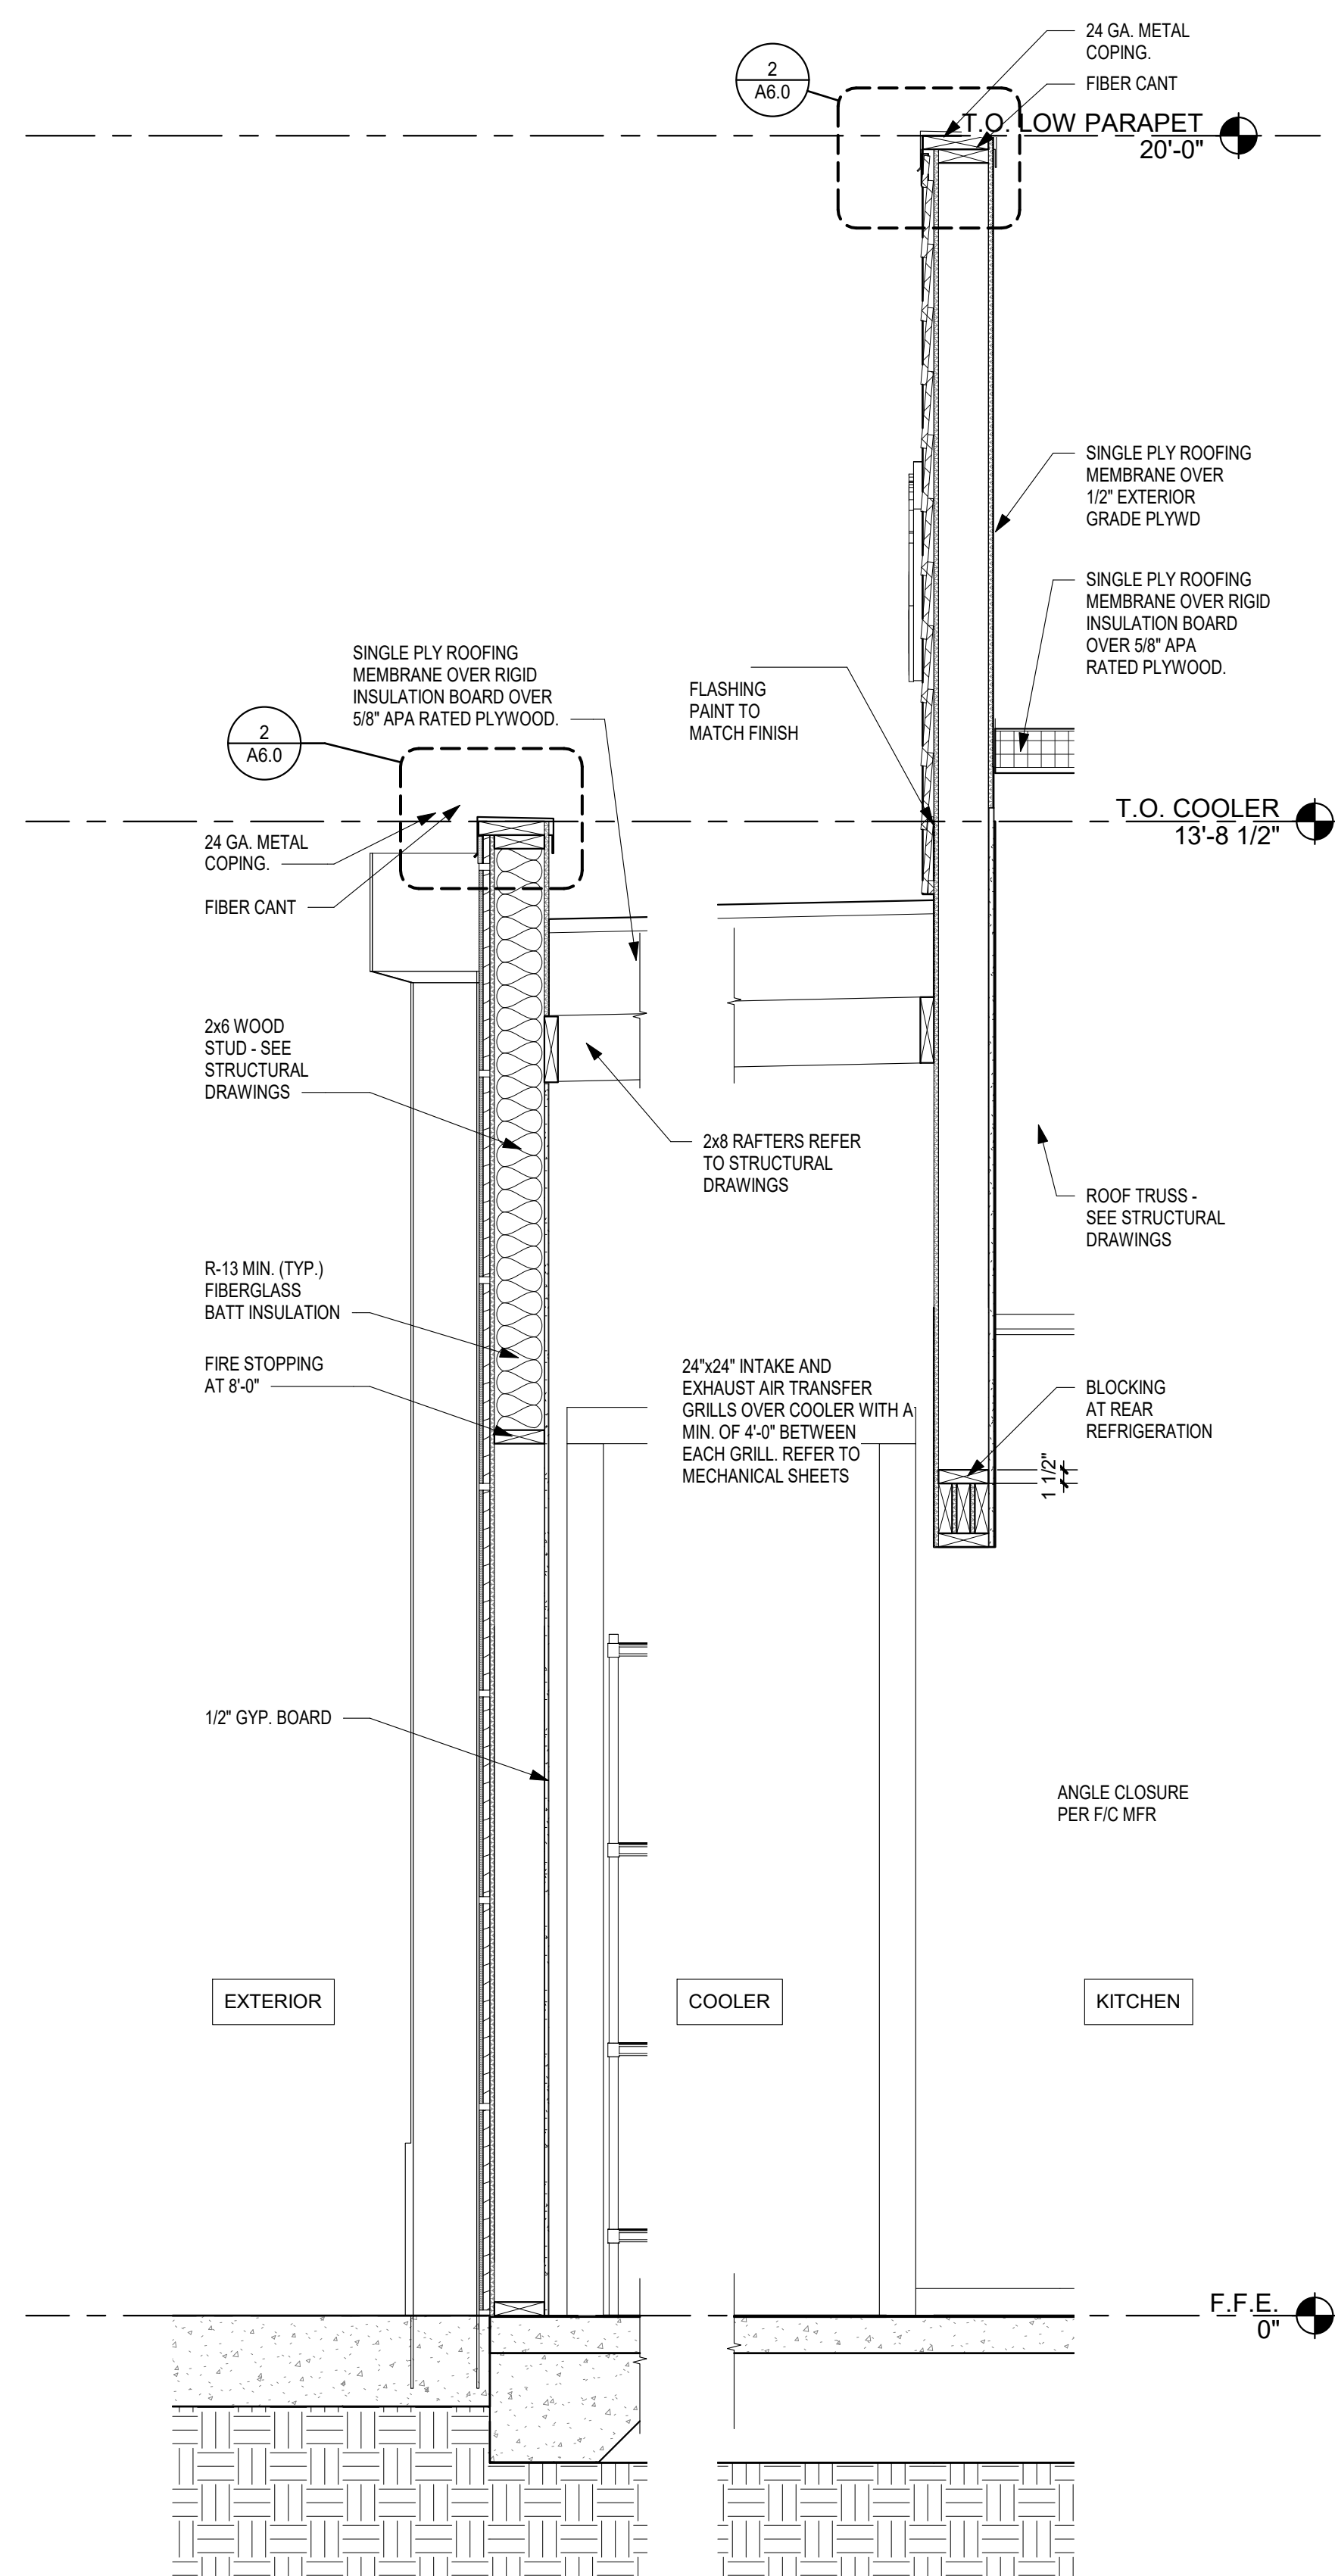

**WALL SECTION AT COOLER** 3/4" = 1'-0"

**WALL SECTION AT WALK-IN COOLER** 3/4" = 1'-0"

**WALL SECTION AT PATIO** 3/4" = 1'-0" **A**

CAUTION: IF THIS SHEET IS NOT 22"x34" IT IS A REDUCED PRINT