

1. COORDINATE SERVICE ENTRANCE SECTION, TRANSFORMER, PRIMARY SERVICE, SECONDARY SERVICE, AND SWITCHING CABINET OR POWER POLE LOCATIONS WITH SERVING UTILITY COMPANY AND COMPLY AS REQUIRED.
2. CONTRACTOR TO BE RESPONSIBLE FOR COORDINATING AND PROVIDING REQUIRED WORK FOR SUPPLYING ELECTRICAL POWER AND TELEPHONE UTILITIES TO THE BUILDING.
3. CONTRACTOR TO PROVIDE ALL TRENCHING, BACKFILL, CONDUIT, PAD, ETC. PER THE SERVING UTILITY COMPANY SHOP DRAWINGS AND SPECIFICATIONS.
4. NOT USED.
5. MINIMUM CIRCUITRY THIS SHEET TO BE #10, 3/4" CONDUIT.


SITE PLAN GENERAL NOTES	2
-------------------------	---

E-105

1. UTILITY CO. PADMOUNT TRANSFORMER, PROVIDE PER UTILITY COMPANY REQUIREMENTS. SEE SINGLE LINE DIAGRAM.
2. UTILITY CO. PRIMARY, PROVIDE CONDUITS BASED ON UTILITY COMPANY REQUIREMENTS. SEE SINGLE LINE DIAGRAM.
3. UTILITY CO. SECONDARY, PROVIDE (2) 4" CONDUITS OR AS DIRECTED BY THE UTILITY COMPANY REQUIREMENTS. SEE SINGLE LINE DIAGRAM.
4. UNDERGROUND TELCO. SERVICE, PROVIDE CONDUITS BASED ON TELEPHONE COMPANY REQUIREMENTS. CONNECT TO TELCO. PRIMARY SERVICE. COORDINATE EXACT ROUTING AND CONNECTION IN FIELD.
5. TELEPHONE CONDUIT TO TURN UP IN FURRED WALL TO ABOVE CEILING AND OVER TO THE TMB ABOVE THE MANAGER STATION.
6. COMBINE MULTIPLE HOMERUNS IN J-BOX ADJACENT PANEL.
7. NOT USED.
8. NOT USED.
9. DRIVE-THRU SENSOR LOOP. COORDINATE LOCATION. REFER TO DETAIL 1 / E-401.
10. STUB-UP FOR DRIVE-THRU ORDER CONFIRMATION MONITOR. COORDINATE LOCATION WITH ARCHITECT / OWNER.
11. STUB-UP LOCATION FOR MENU BOARD. SIGN DISCONNECT PROVIDED BY SIGN CONTRACTOR. COORDINATE PRECISE LOCATION WITH ARCHITECT / OWNER.
12. STUB-UP LOCATION FOR (3) 3/4" CONDUITS □ PULL STRINGS, TO ENTER BUILDING □ UP TO 6" ABOVE CEILING. REFER TO SHEET 1 / E-401.


SITE PLAN KEYED NOTES	3
-----------------------	---

E-105

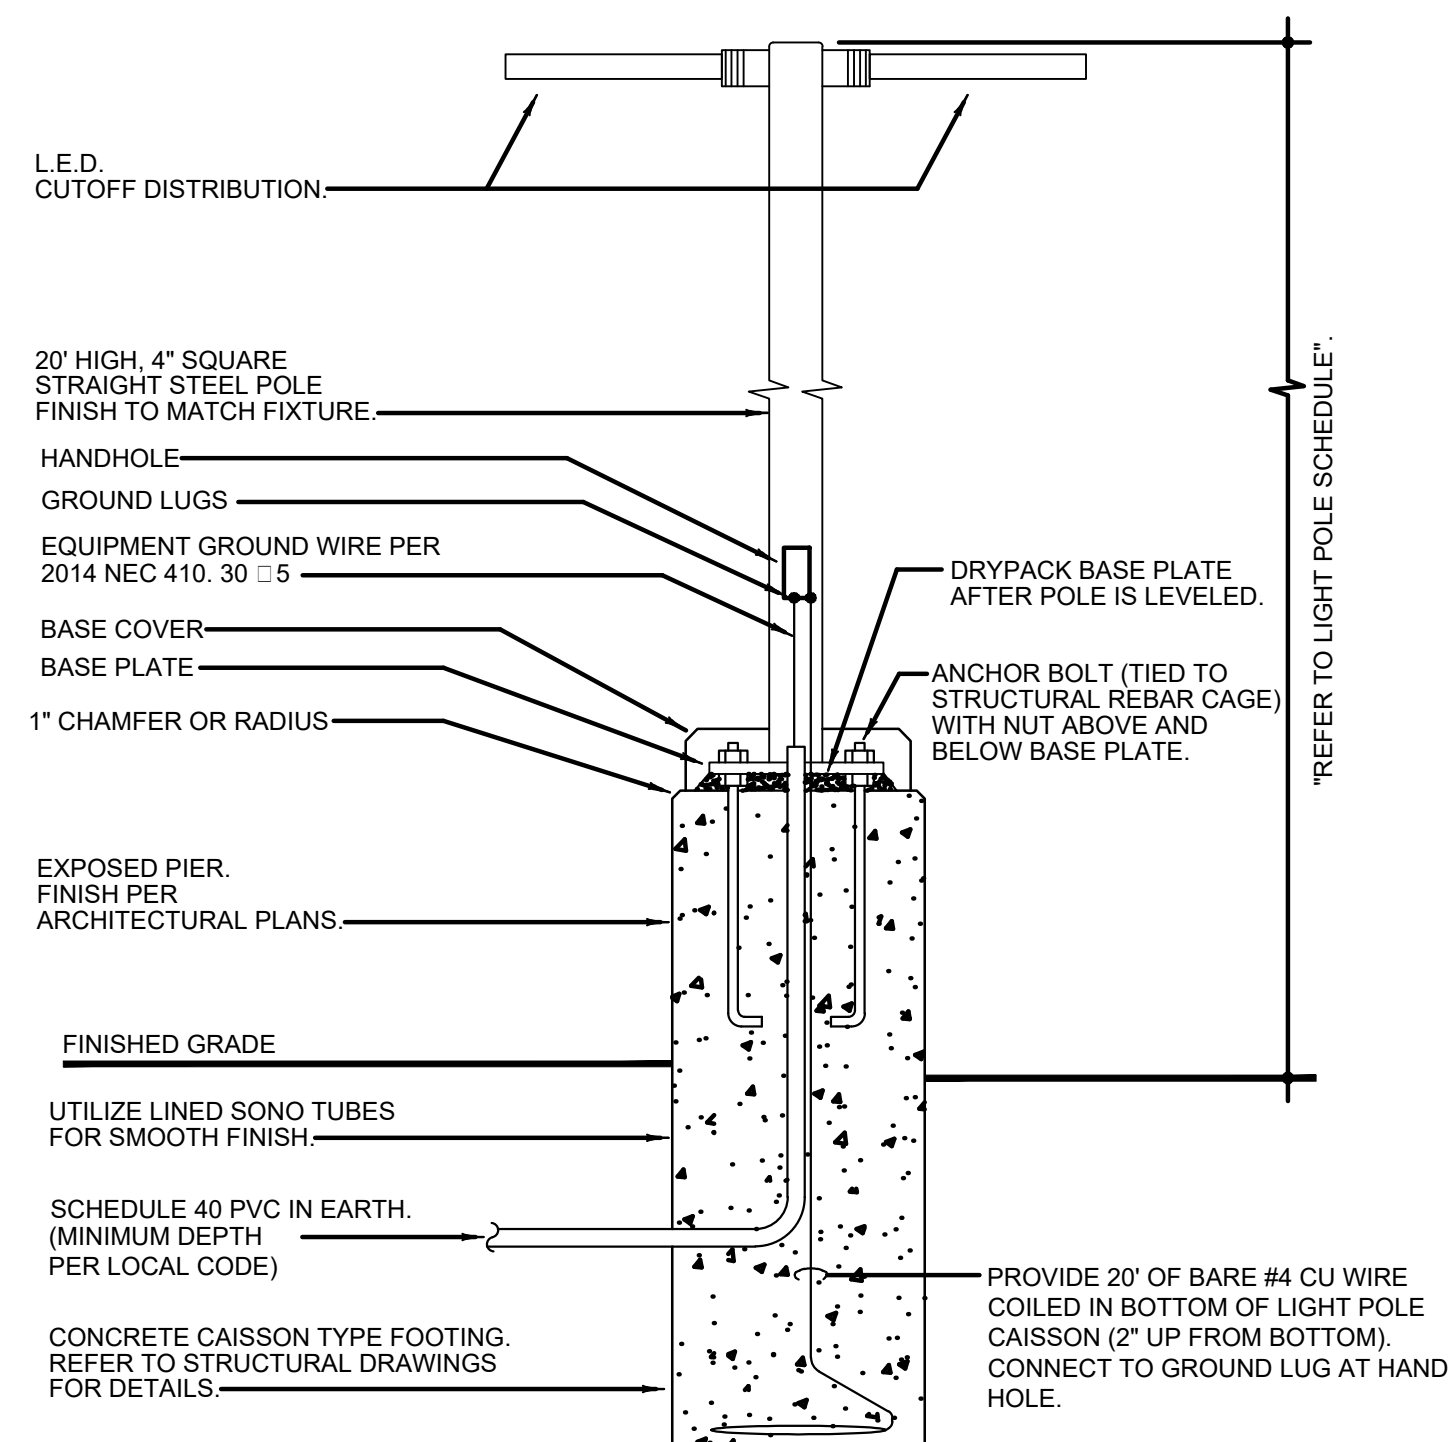

POLE MOUNTING DETAILS	4
-----------------------	---

NO SCALE	E-106
----------	-------

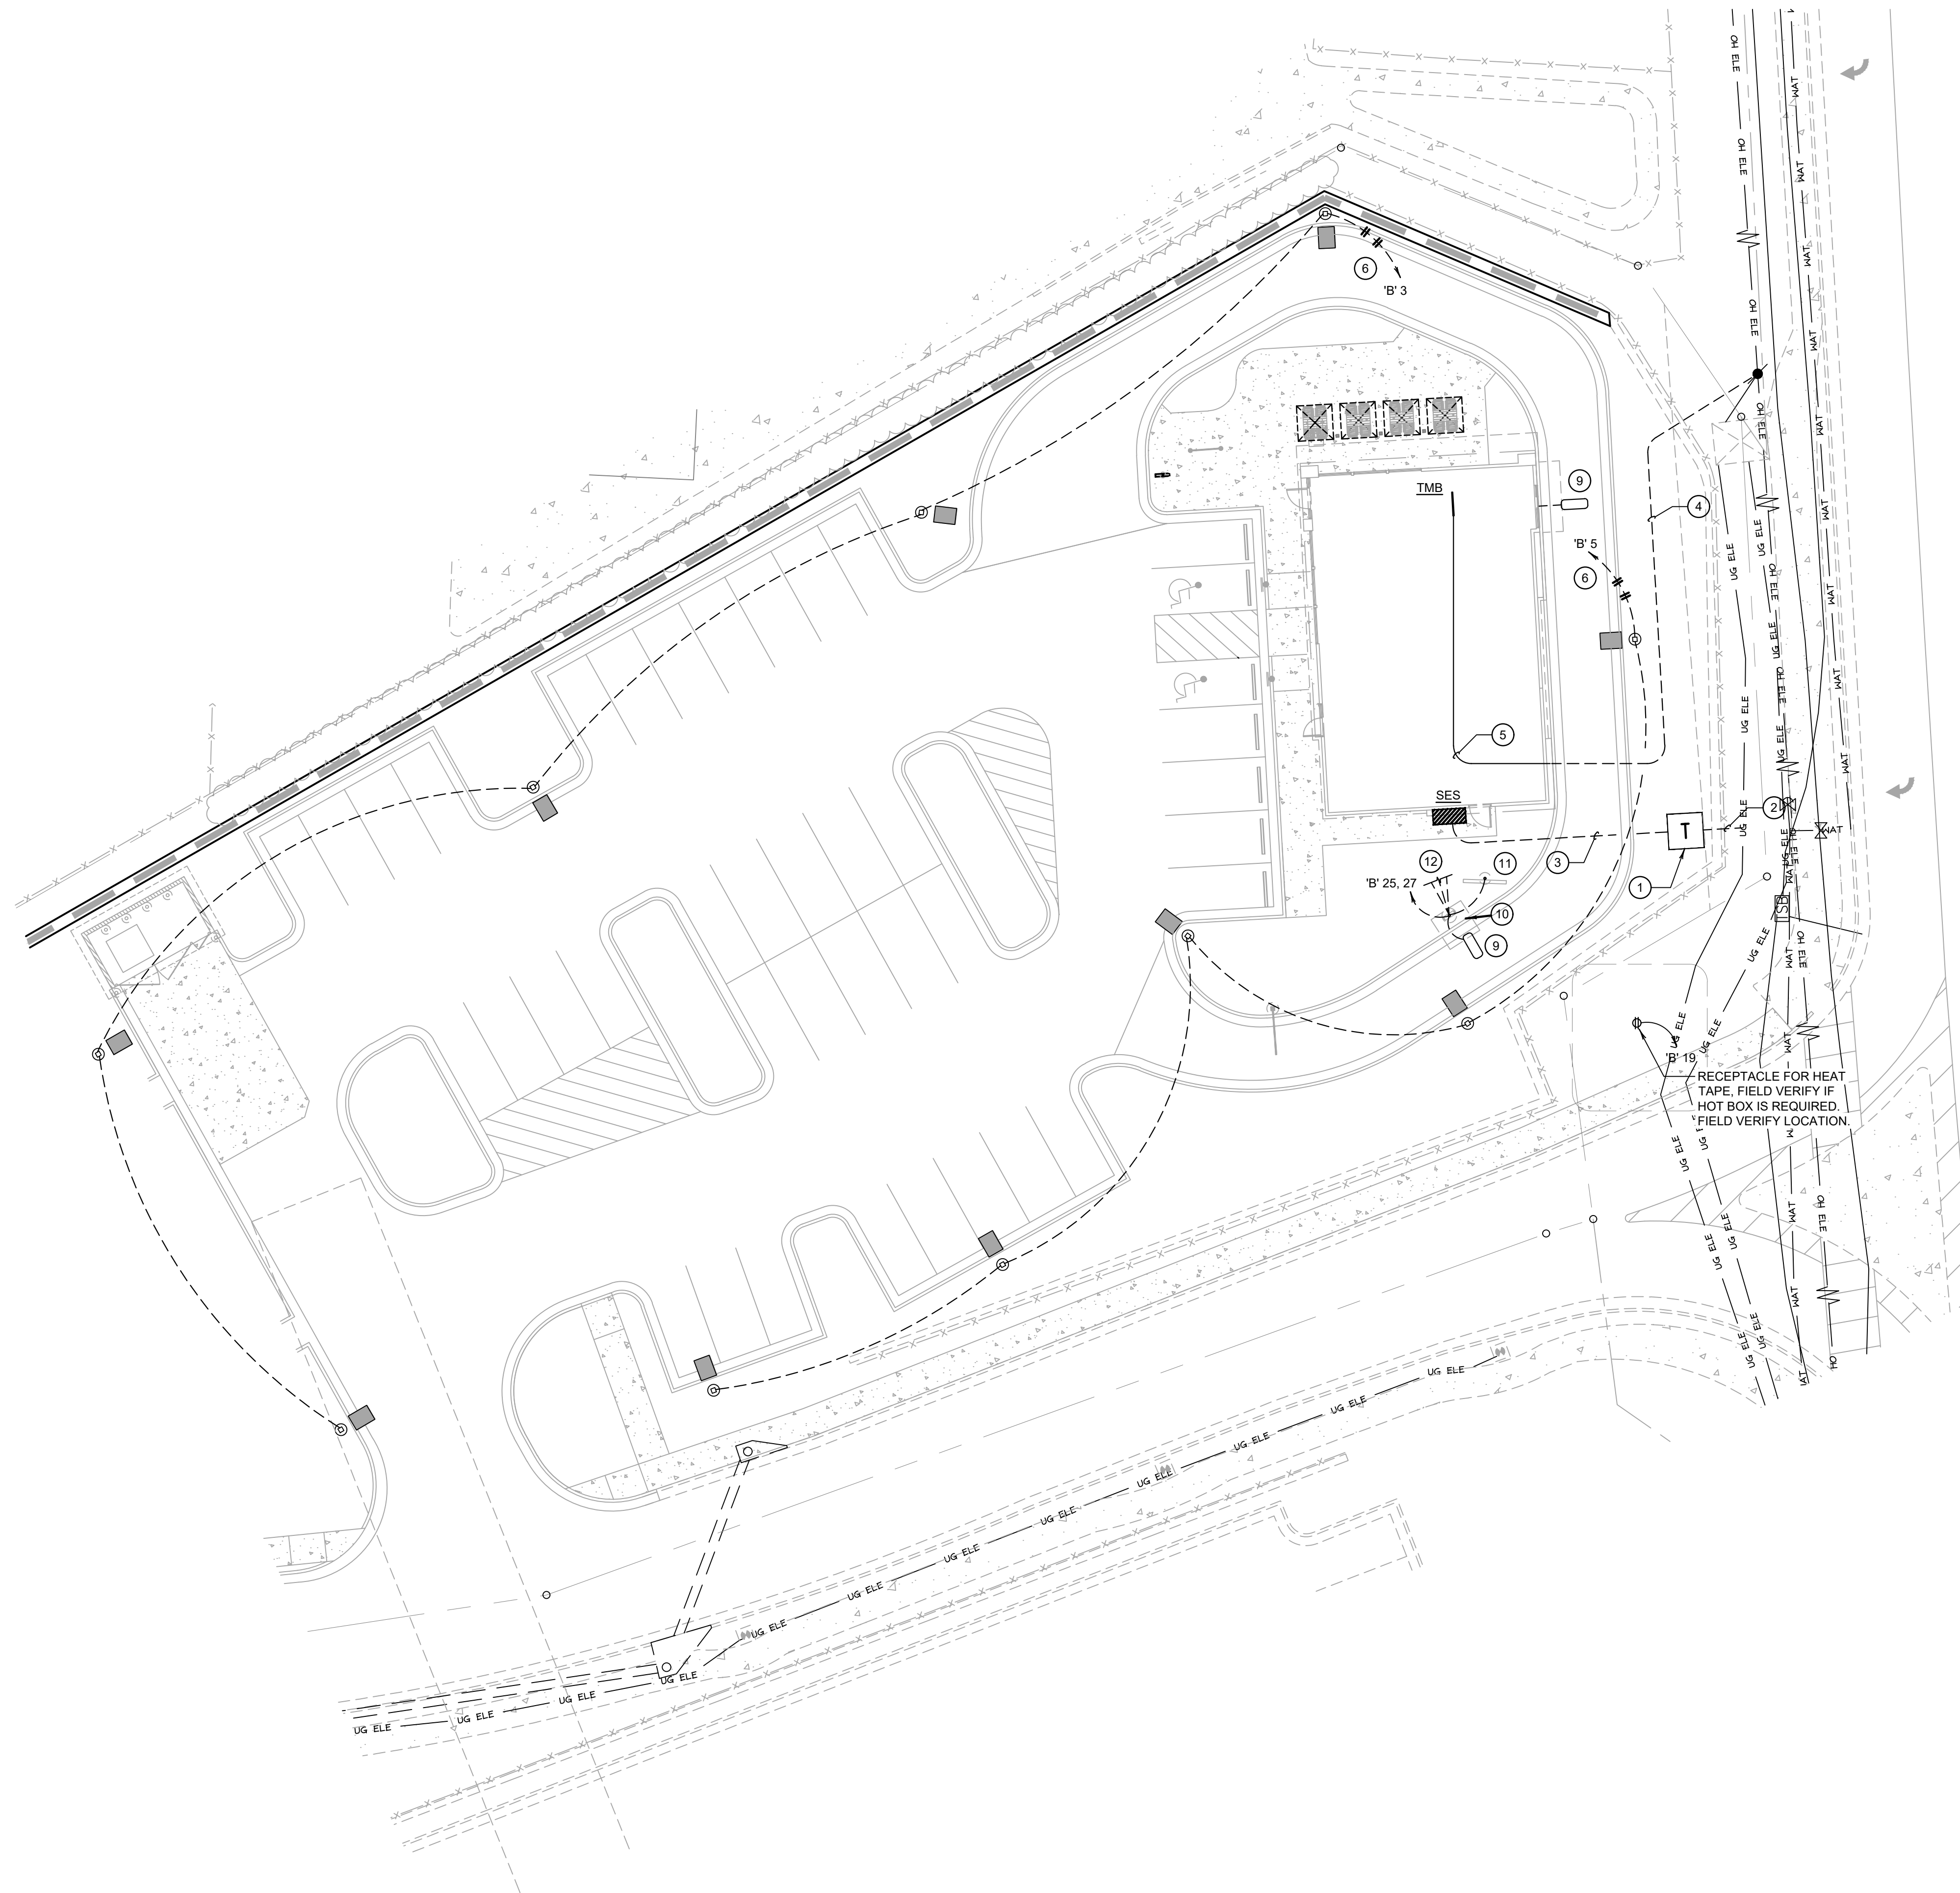

SITE & EXTERIOR LIGHTING PLAN

1

1" = 16'-0"	E-105
-------------	-------



PANDA RESTAURANT GROUP INC.
1683 Walnut Grove Ave.
Rosemead, California
91770
Telephone: 626.799.9898
Facsimile: 626.372.8288

All ideas, designs, arrangement and plans indicated or represented by this drawing are the property of Panda Express Inc. and were created for use on this specific project. None of these ideas, designs, arrangements or plans may be used by or disclosed to any person, firm, or corporation without the written permission of Panda Express Inc.

REVISIONS:

[illegible]

ISSUE DATE:

1st	ISSUE FOR PERMIT	02-15-17
2nd	ISSUE FOR BID	02-22-17

DRAWN BY:

PANDA PROJECT #: S8-17-D4968
ARCH PROJECT #: 1703

Project No.
PE1703



**Kurzynske
& Associates**
CONSULTING ENGINEERS
2900 Lebanon Pike
Suite 201
Nashville, Tennessee 37214



2-21-2017

PANDA EXPRESS

Terrence at Suwanee Gateway (in front of Lowe's)
3276 LAWRENCEVILLE-SUWANEE RD
SUWANEE, GA

2200 TRUE WARM & WELCOME

E-105

HOT - MEDIUM
SITE & EXTERIOR LIGHTING PLAN

TRUE WARM & WELCOME 2200